


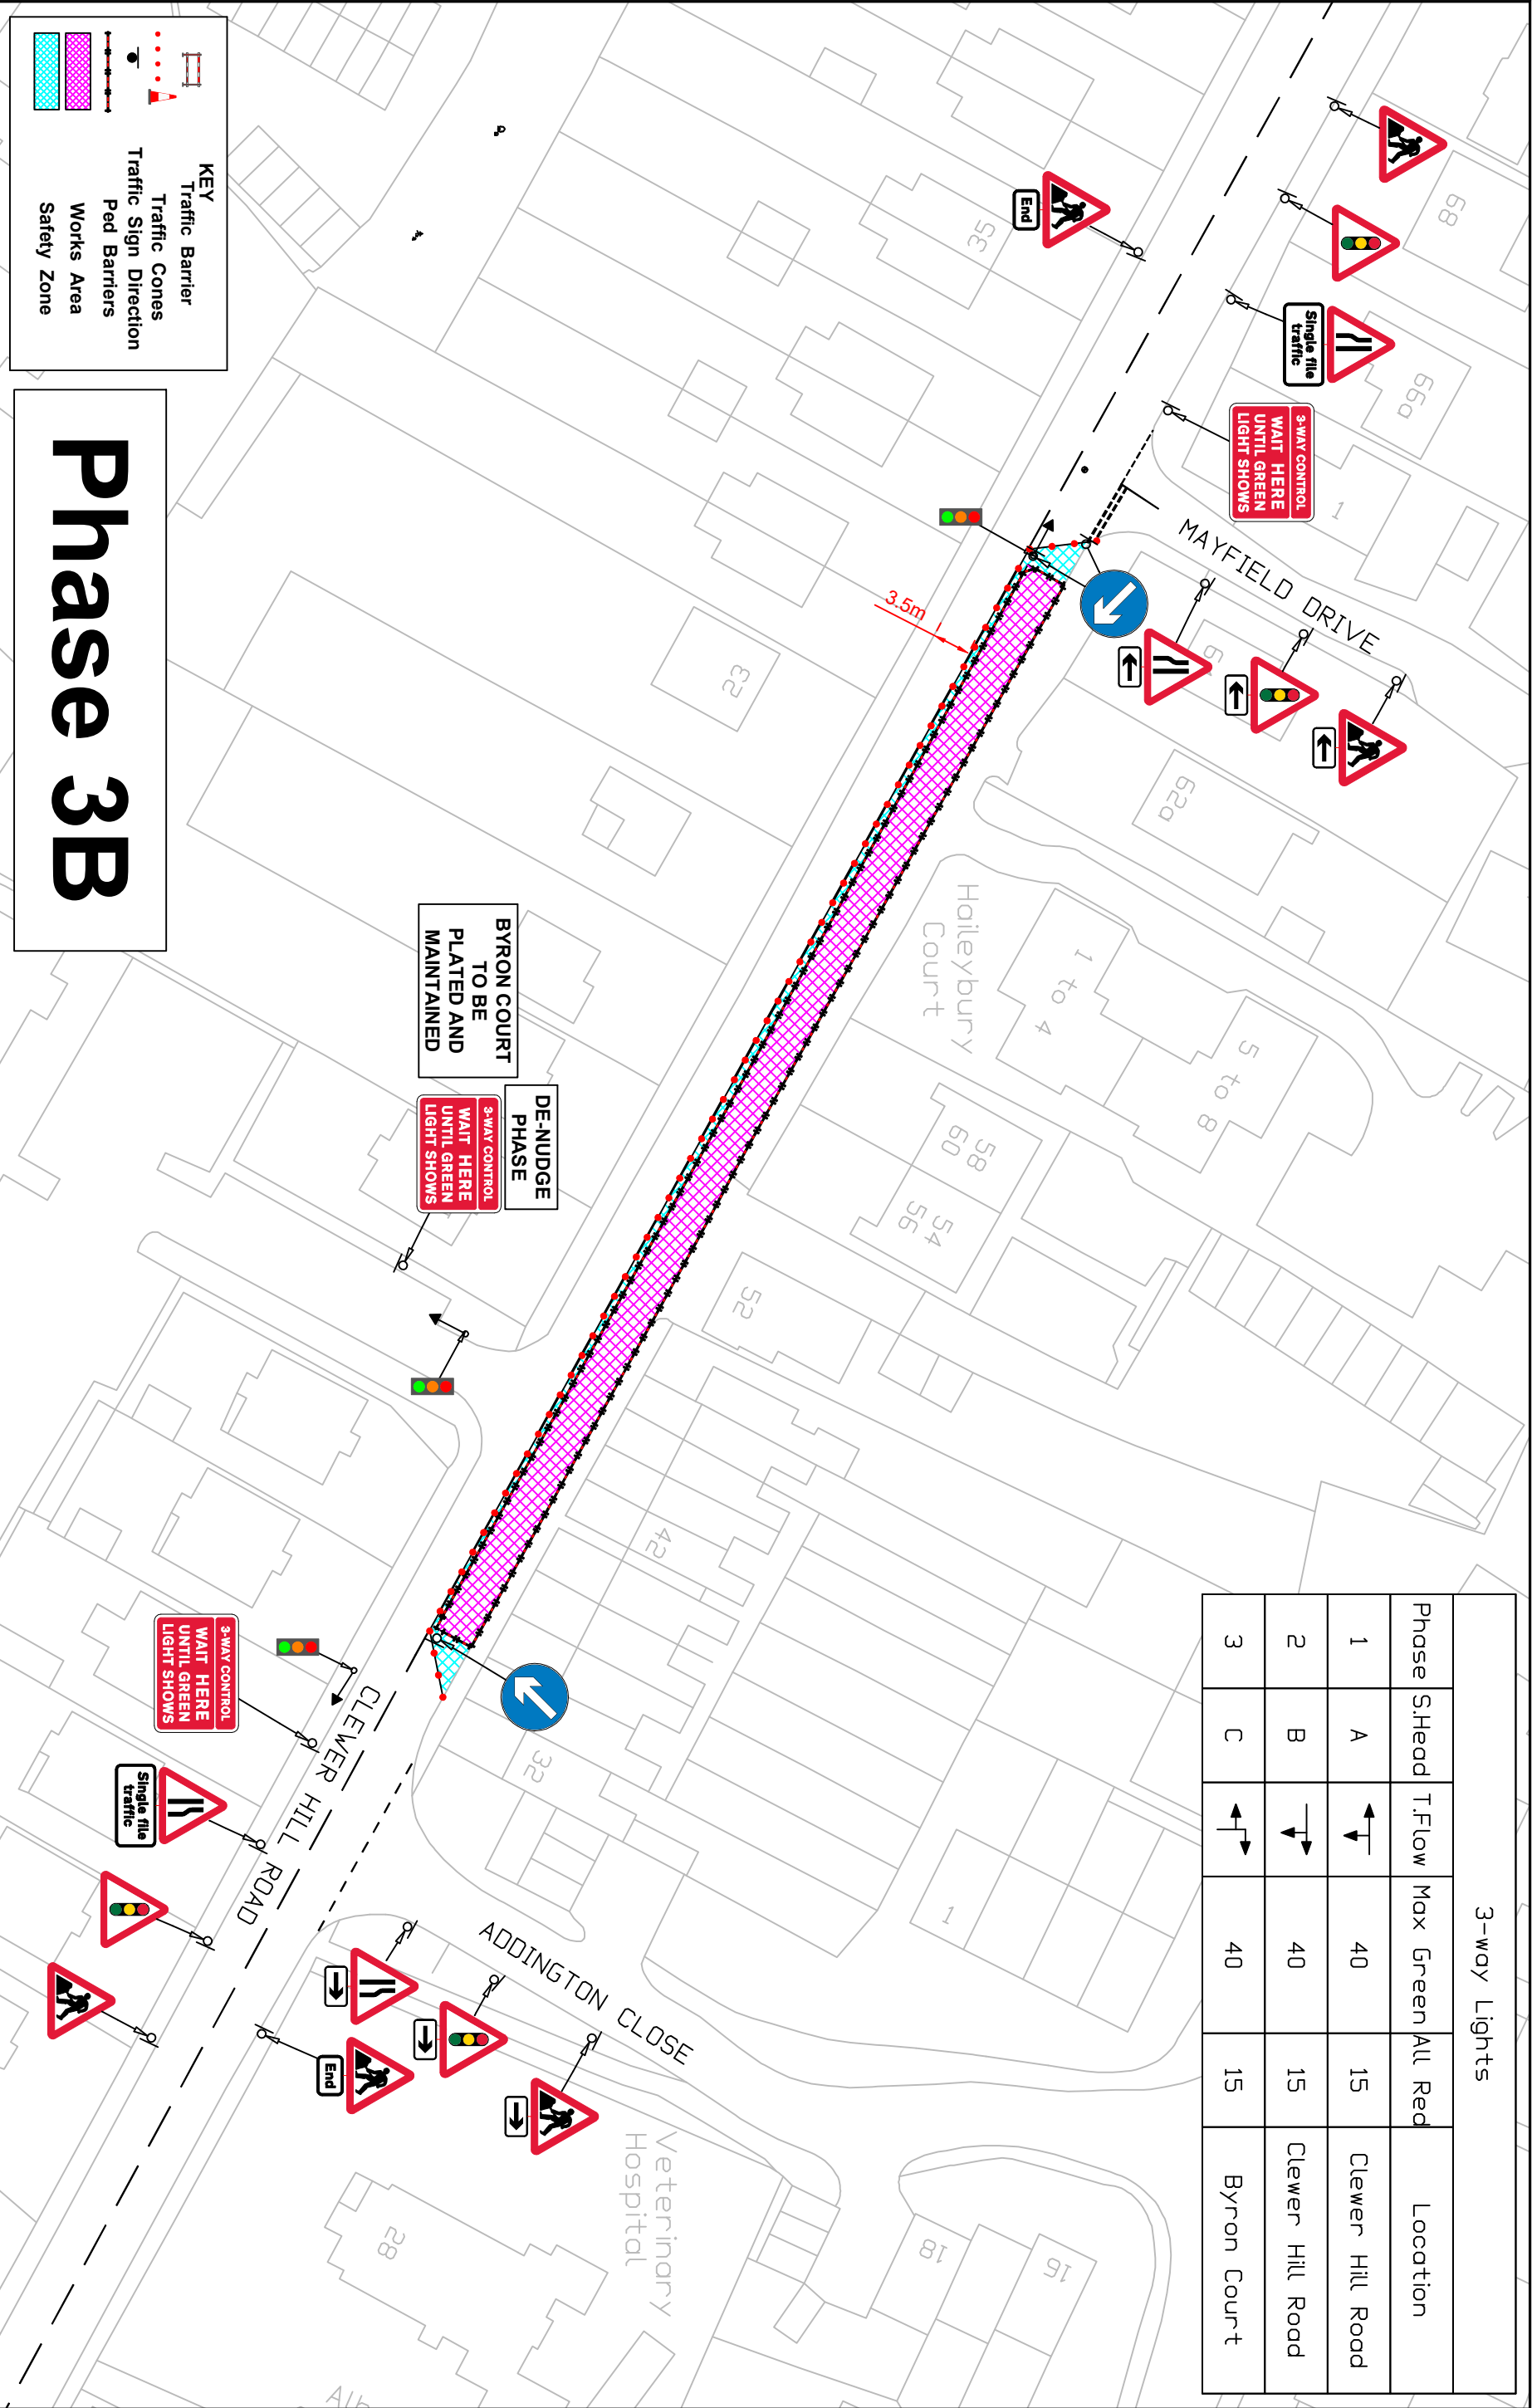



3-way Lights					
Phase	S.Head	T.Flow	Max Green	All Red	Location
1	A		40	15	Clewer Hill Road
2	B		40	15	Clewer Hill Road
3	C		40	15	Byron Court




# Phase 3B


KEY




Traffic Barrier




Traffic Cones




Traffic Sign Direction




Ped Barriers




Works Area




Safety Zone




MGROUP  
Water





CLEWER HILL ROAD  
WINDSOR  
SL4 4BS



Traffic Guarding & Logistics  
TGL Group Ltd

Units 3, 4 & 5 River Moles Business Park  
Mill Mead Road, Esher,  
Surrey KT10 8BJ  
Tel: 0800 6444 114  
Web: www.tglogroup.co.uk  
Email : tmdrawings@tglogroup.co.uk

1) TEMPORARY TRAFFIC MANAGEMENT TO BE SET OUT IN ACCORDANCE WITH CHAPTER 8 AND SAFE WORKING PRACTICES.  
2) ALL BUS, PARKING AND LOADING BAYS SHOULD BE SUSPENDED WITH THE RELEVANT AUTHORITY PRIOR TO COMMENCEMENT OF WORK.  
3) WORKS VEHICLES TO BE PARKED WITHIN WORKS AREA.

DATE DRAWN06/05/25  
DRAWN BYTGL DDC  
CHECKED BYTGL CJ  
SCALEN.T.S.

Drawing No.  
1205.94.3B