


4-way Lights & Pedestrians				
Phase	S.Head	T.Flow	Max Green	All Red
1	A		40	15
2	B		40	15
3	C		40	15
4	D		40	15
5	E		7	5

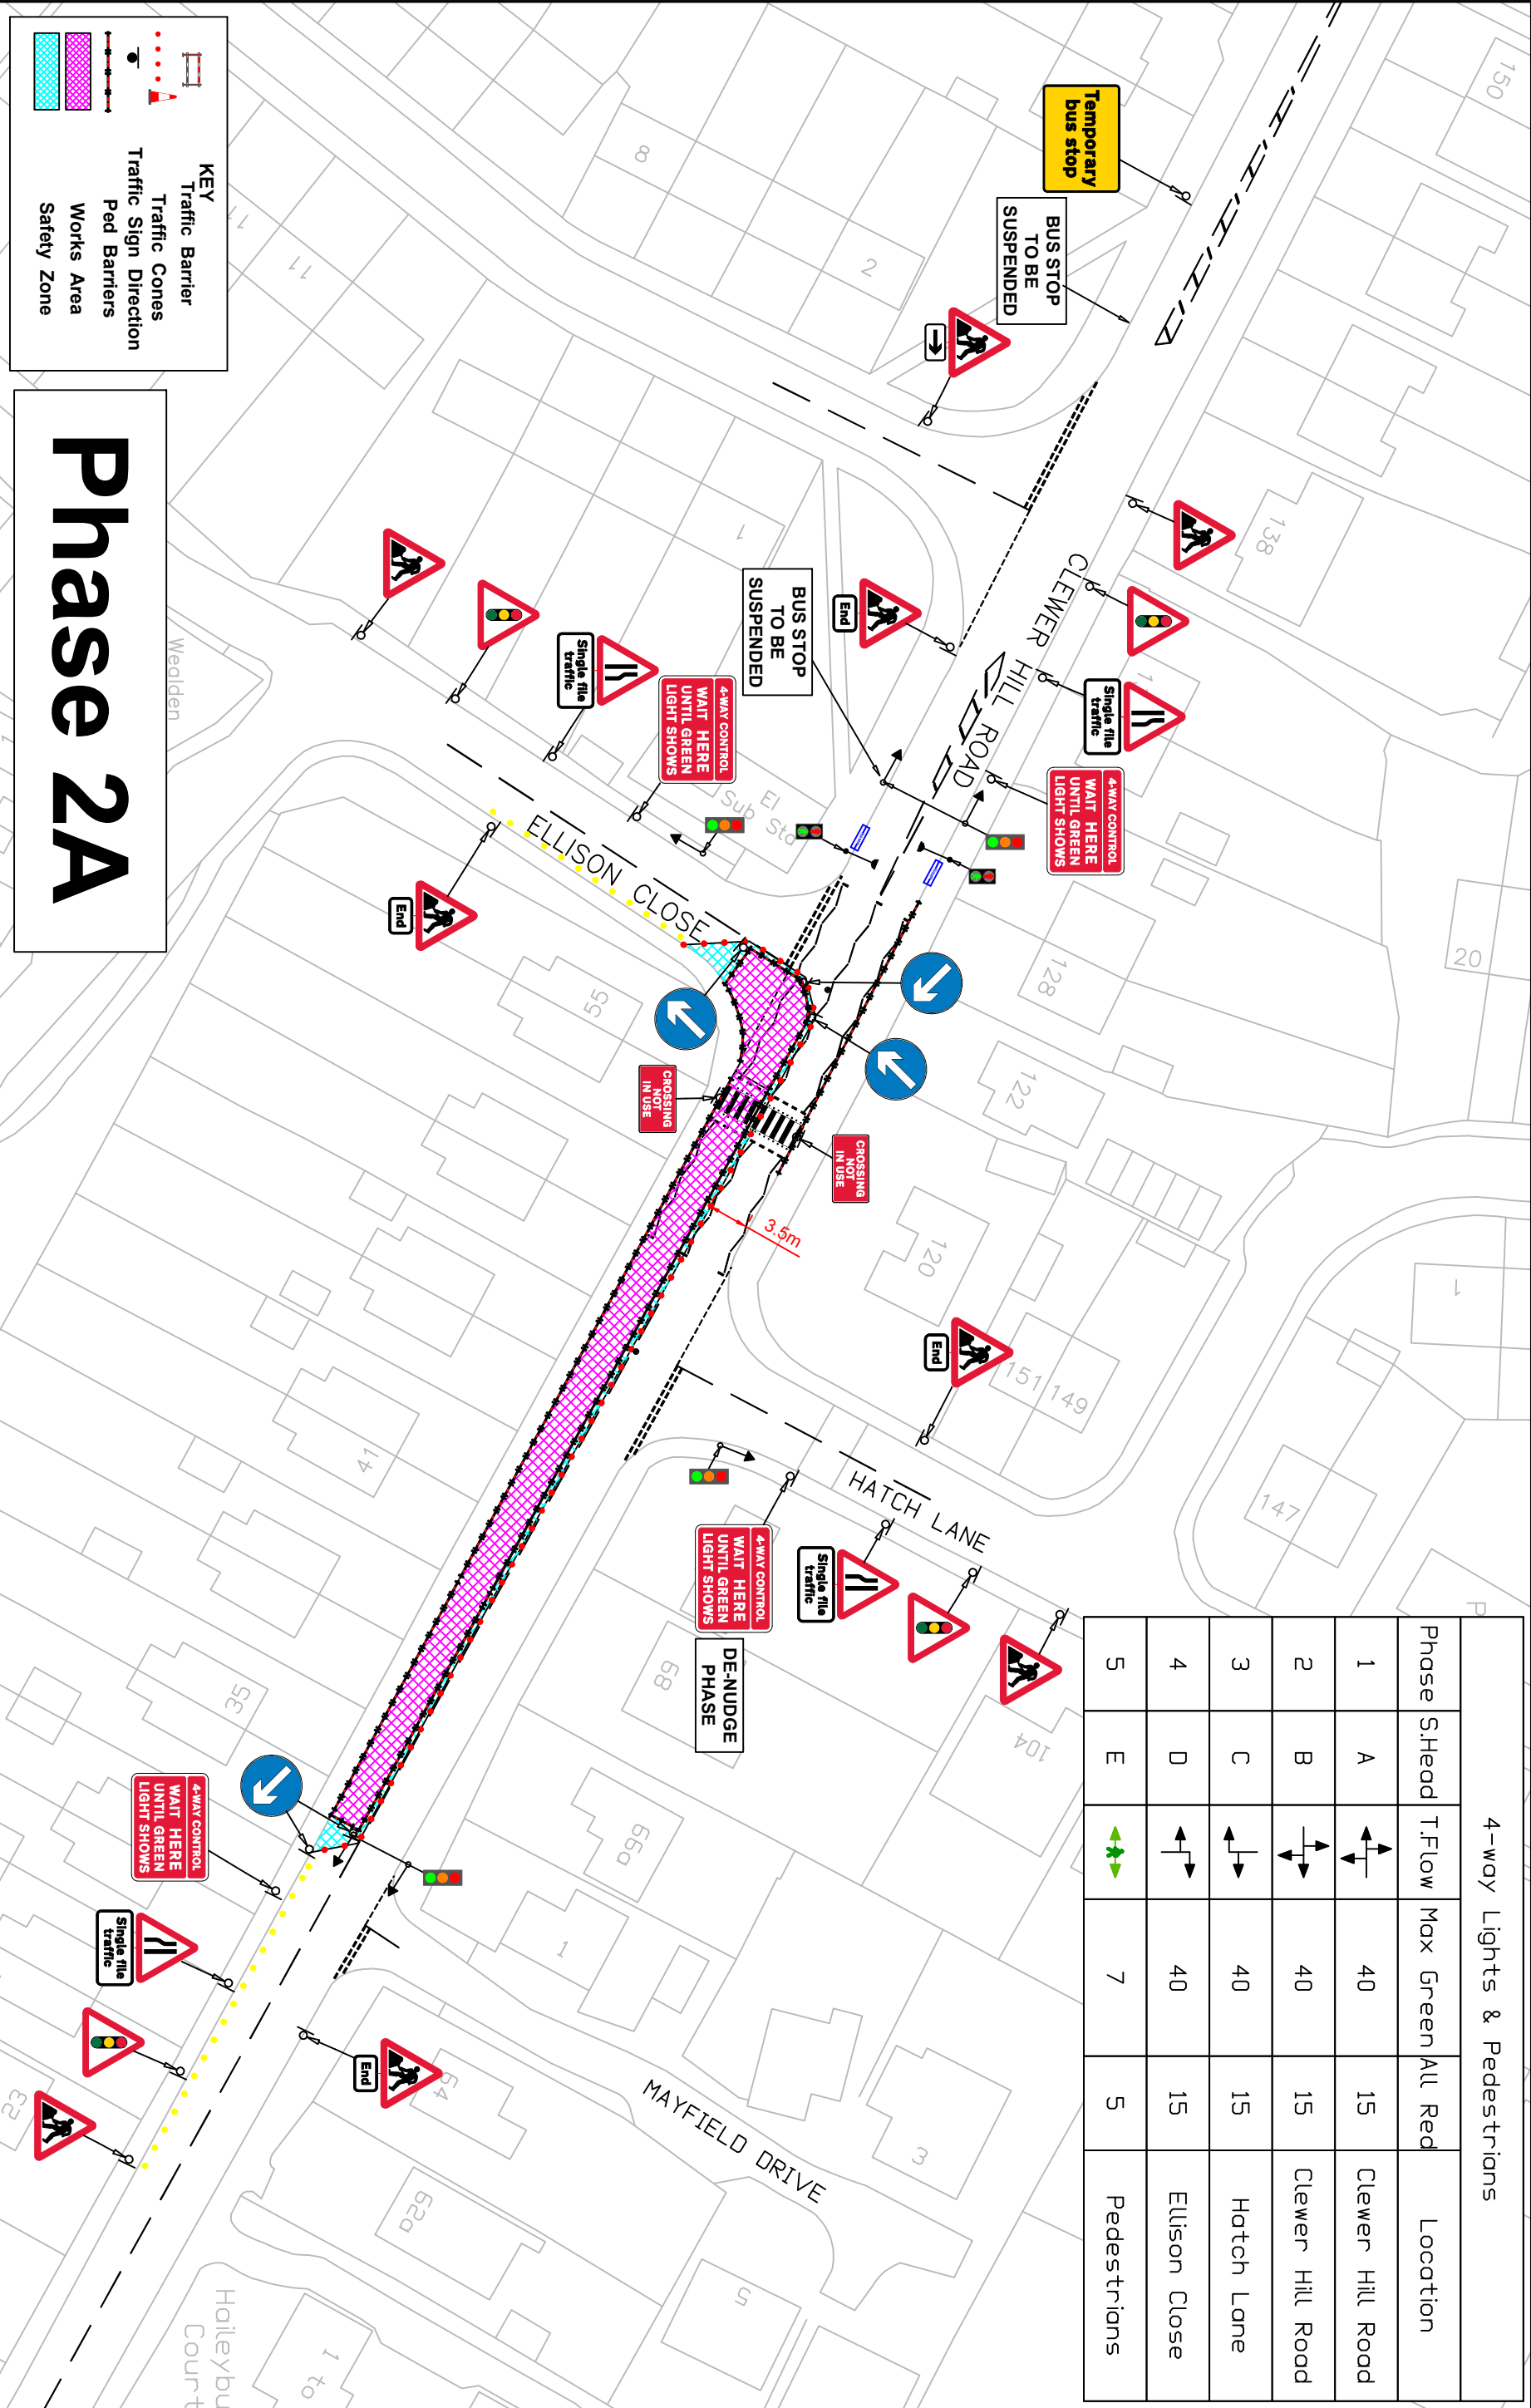

KEY

Traffic Barrier

Traffic Cones

Ped Sign Direction

Works Area

Safety Zone

Phase 2A

CLEWER HILL ROAD
WINDSOR
SL4 4BS

Units 3, 4 & 5 River Moles Business Park
Mill Mead Road, Esher,
Surrey KT10 8BJ
Tel: 0800 6444 114
Web: www.tglogroup.co.uk
Email: tmdrawings@tglogroup.co.uk

1) TEMPORARY TRAFFIC MANAGEMENT TO BE SET OUT IN ACCORDANCE WITH CHAPTER 8 AND SAFE WORKING PRACTICES.

2) ALL BUS, PARKING AND LOADING BAYS SHOULD BE SUSPENDED WITH THE RELEVANT AUTHORITY PRIOR TO COMMENCEMENT OF WORK.

3) WORKS VEHICLES TO BE PARKED WITHIN WORKS AREA.

DATE DRAWN 06/05/25

DRAWN BY TGL DDC

CHECKED BY TGL CJ

SCALE N.T.S.

Drawing No.

1205.94.4A