


3-way Lights & Pedestrians				
Phase	S.Head	T.Flow	Max Green	All Red
1	A		40	15
2	B		40	15
3	C		40	15
4	D		7	5

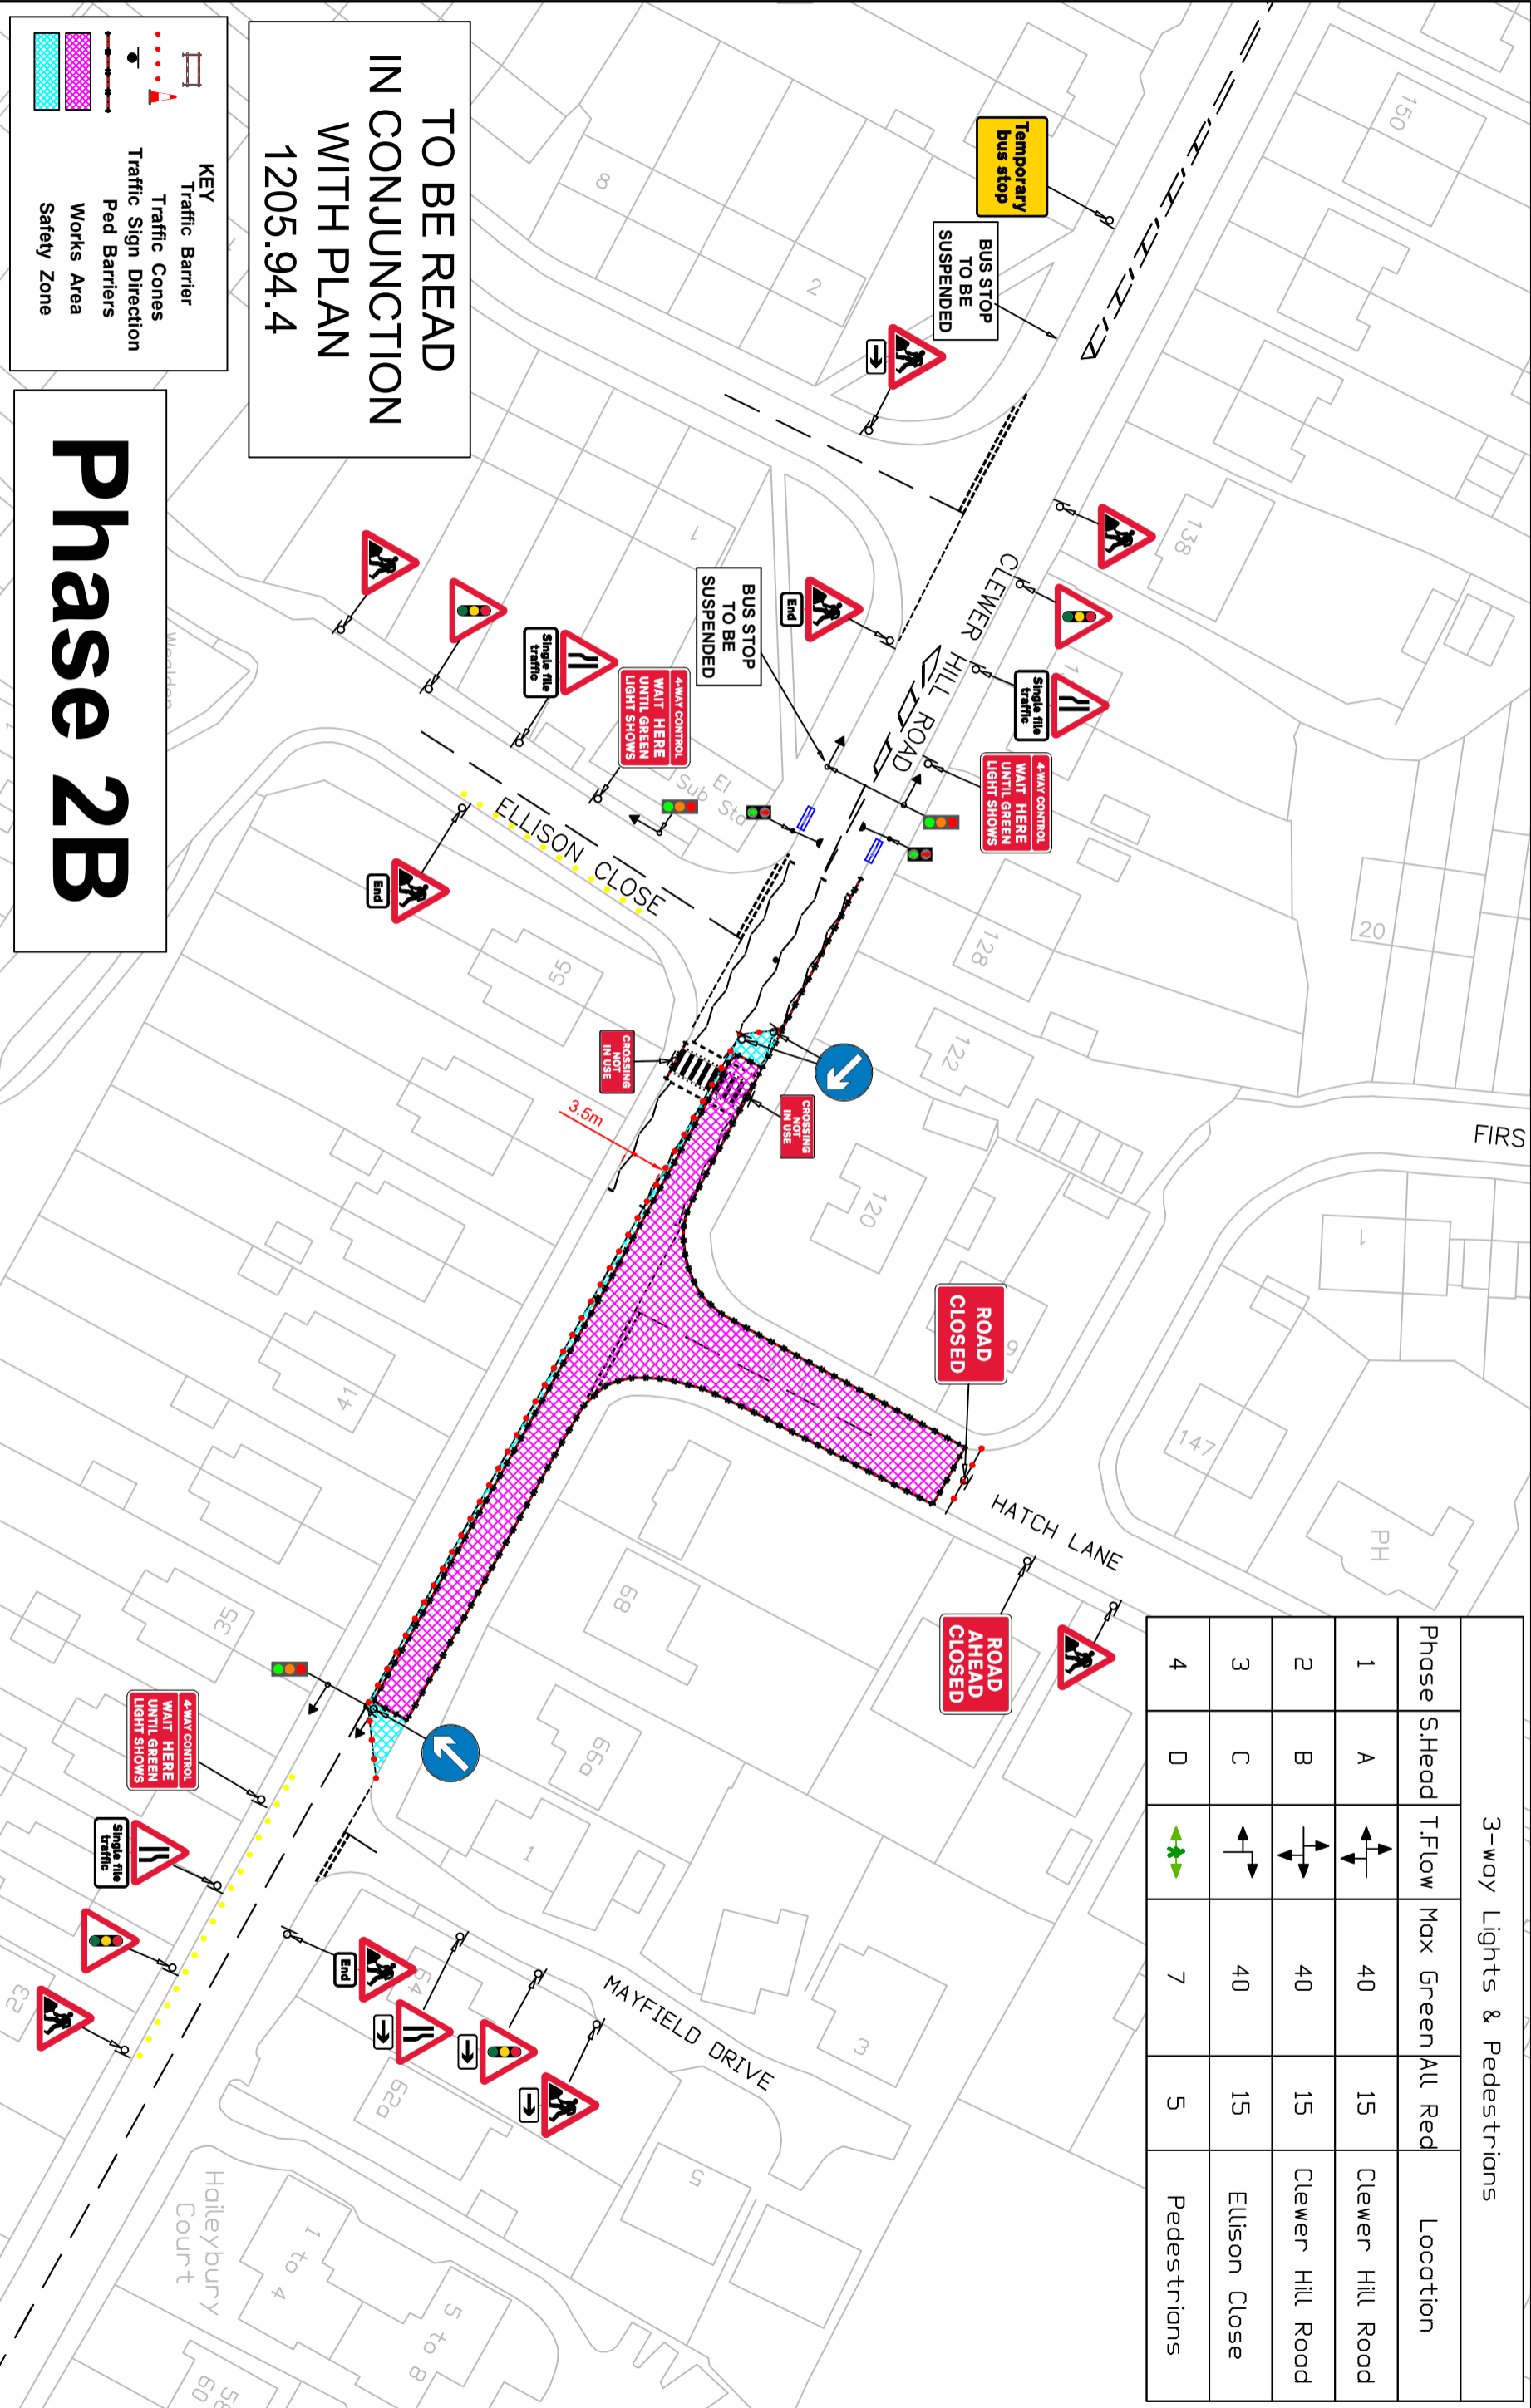

Phase 2B

TO BE READ
IN CONJUNCTION
WITH PLAN
1205.94.4

KEY

Traffic Barrier

Traffic Cones

Ped Barriers

Works Area

Safety Zone

MGROUP
Water

CLEWER HILL ROAD
WINDSOR
SL4 4BS

Traffic Guarding & Logistics
TGL Group Ltd

Units 3, 4 & 5 River Moles Business Park
Mill Mead Road, Esher,
Surrey KT10 8BJ
Tel: 0800 6444 114
Web: www.tglogroup.co.uk
Email : tmdrawings@tglogroup.co.uk

1) TEMPORARY TRAFFIC MANAGEMENT TO BE SET OUT IN ACCORDANCE WITH CHAPTER 8 AND SAFE WORKING PRACTICES.
2) ALL BUS, PARKING AND LOADING BAYS SHOULD BE SUSPENDED WITH THE RELEVANT AUTHORITY PRIOR TO COMMENCEMENT OF WORK.
3) WORKS VEHICLES TO BE PARKED WITHIN WORKS AREA.

DATE DRAWN06/05/25
DRAWN BYTGL DDC
CHECKED BYTGL CJ
SCALEN.T.S.

Drawing No.
1205.94.4B