



BROWNE

NOTES:

1. All signs and cones to be in accordance with Chapter 8-2009, the TSRGD and current IAN's.
2. Works access and egress are indicative, exact locations to be agreed on site.
3. Safety zones are to be installed as required.
4. All signs to be located so as not to obscure signs or objects and should be ballasted near to ground level using sand filled hessian bags or sign straps.
5. All sign positions are indicative only and must be accurately positioned on site with good visibility and be clear of and obstructions or vegetation at all times.
6. Drawing not to scale
7. TM will comply with the Safety at Street Works and Road Works Code of Practice

Sign Schedule				
	ID: 001	Item: Pedestrians Use Other Footway	Qty: 10	Ref: 7018
	ID: 002	Item: Pedestrian diversion Right	Qty: 2	Ref: 7018
	ID: 003	Item: Pedestrian diversion Left	Qty: 2	Ref: 7018
	ID: 004	Item: Crossing not in use (sign for pedestrians)	Qty: 4	Ref: 7016
	ID: 005	Item: End panel	Qty: 4	Ref: 645
	ID: 006	Item: Works traffic only	Qty: 1	Ref: 7301
	ID: 007	Item: Works exit	Qty: 1	Ref: 7302
	ID: 008	Item: Direction to hazard left	Qty: 1	Ref: 573
	ID: 009	Item: Direction to hazard right	Qty: 3	Ref: 573
	ID: 010	Item: Road narrows on one side only ahead - right	Qty: 2	Ref: 517
	ID: 011	Item: Road works ahead	Qty: 9	Ref: 7001
	ID: 012	Item: Road narrows on one side only ahead - left	Qty: 2	Ref: 517
	ID: 013	Item: Keep left	Qty: 2	Ref: 610
	ID: 014	Item: Lane closure barrier	Qty: 1	Ref: 7105
	ID: 015	Item: Keep right	Qty: 3	Ref: 610

Minimum Longways safety zone 0.5M Min	(L)	Minimum Sideways safety zone 0.5M Min	(S)
---------------------------------------	-----	---------------------------------------	-----

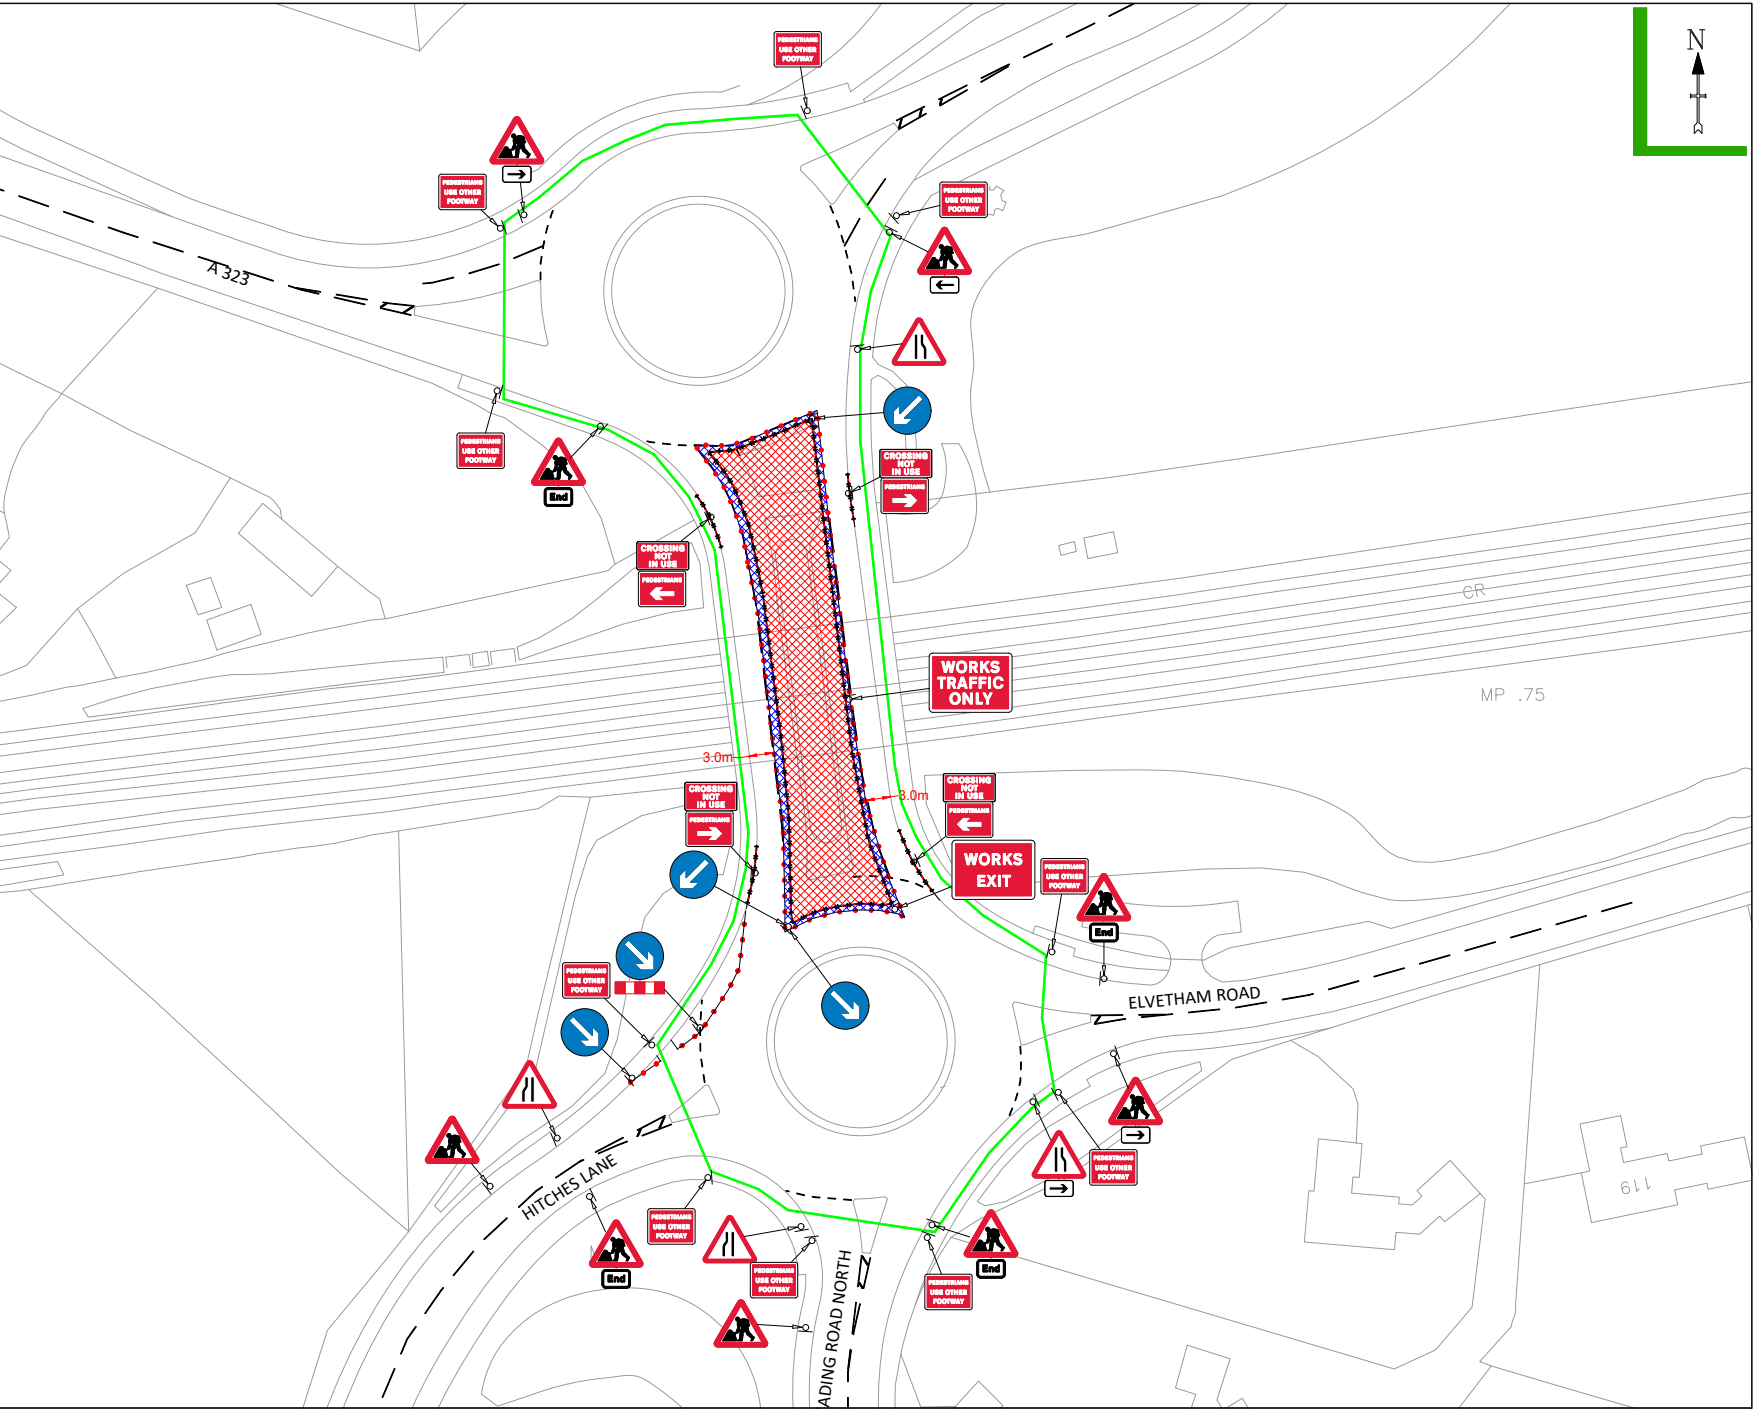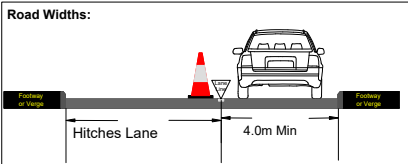

KEY:	
	SAFETY ZONE
	WORK AREA
	SPOIL AREA
	CONE
	PED BARRIER
	NO PARKING CONE
	Bus stop suspension
	Parking Bay suspension

DETAILS OF THE ROAD	
	Hitches Lane

Drawn By	DDC	Traffic Management	Road Narrows
Checked By	MT	Road Name	Hitches Lane
Survey By	Client	Borough/Council	Hampshire
Date Drawn	07/10/2025	Postcode	GU51 1BE
Drawing No	K78937 - PH2 v2		