
 

 

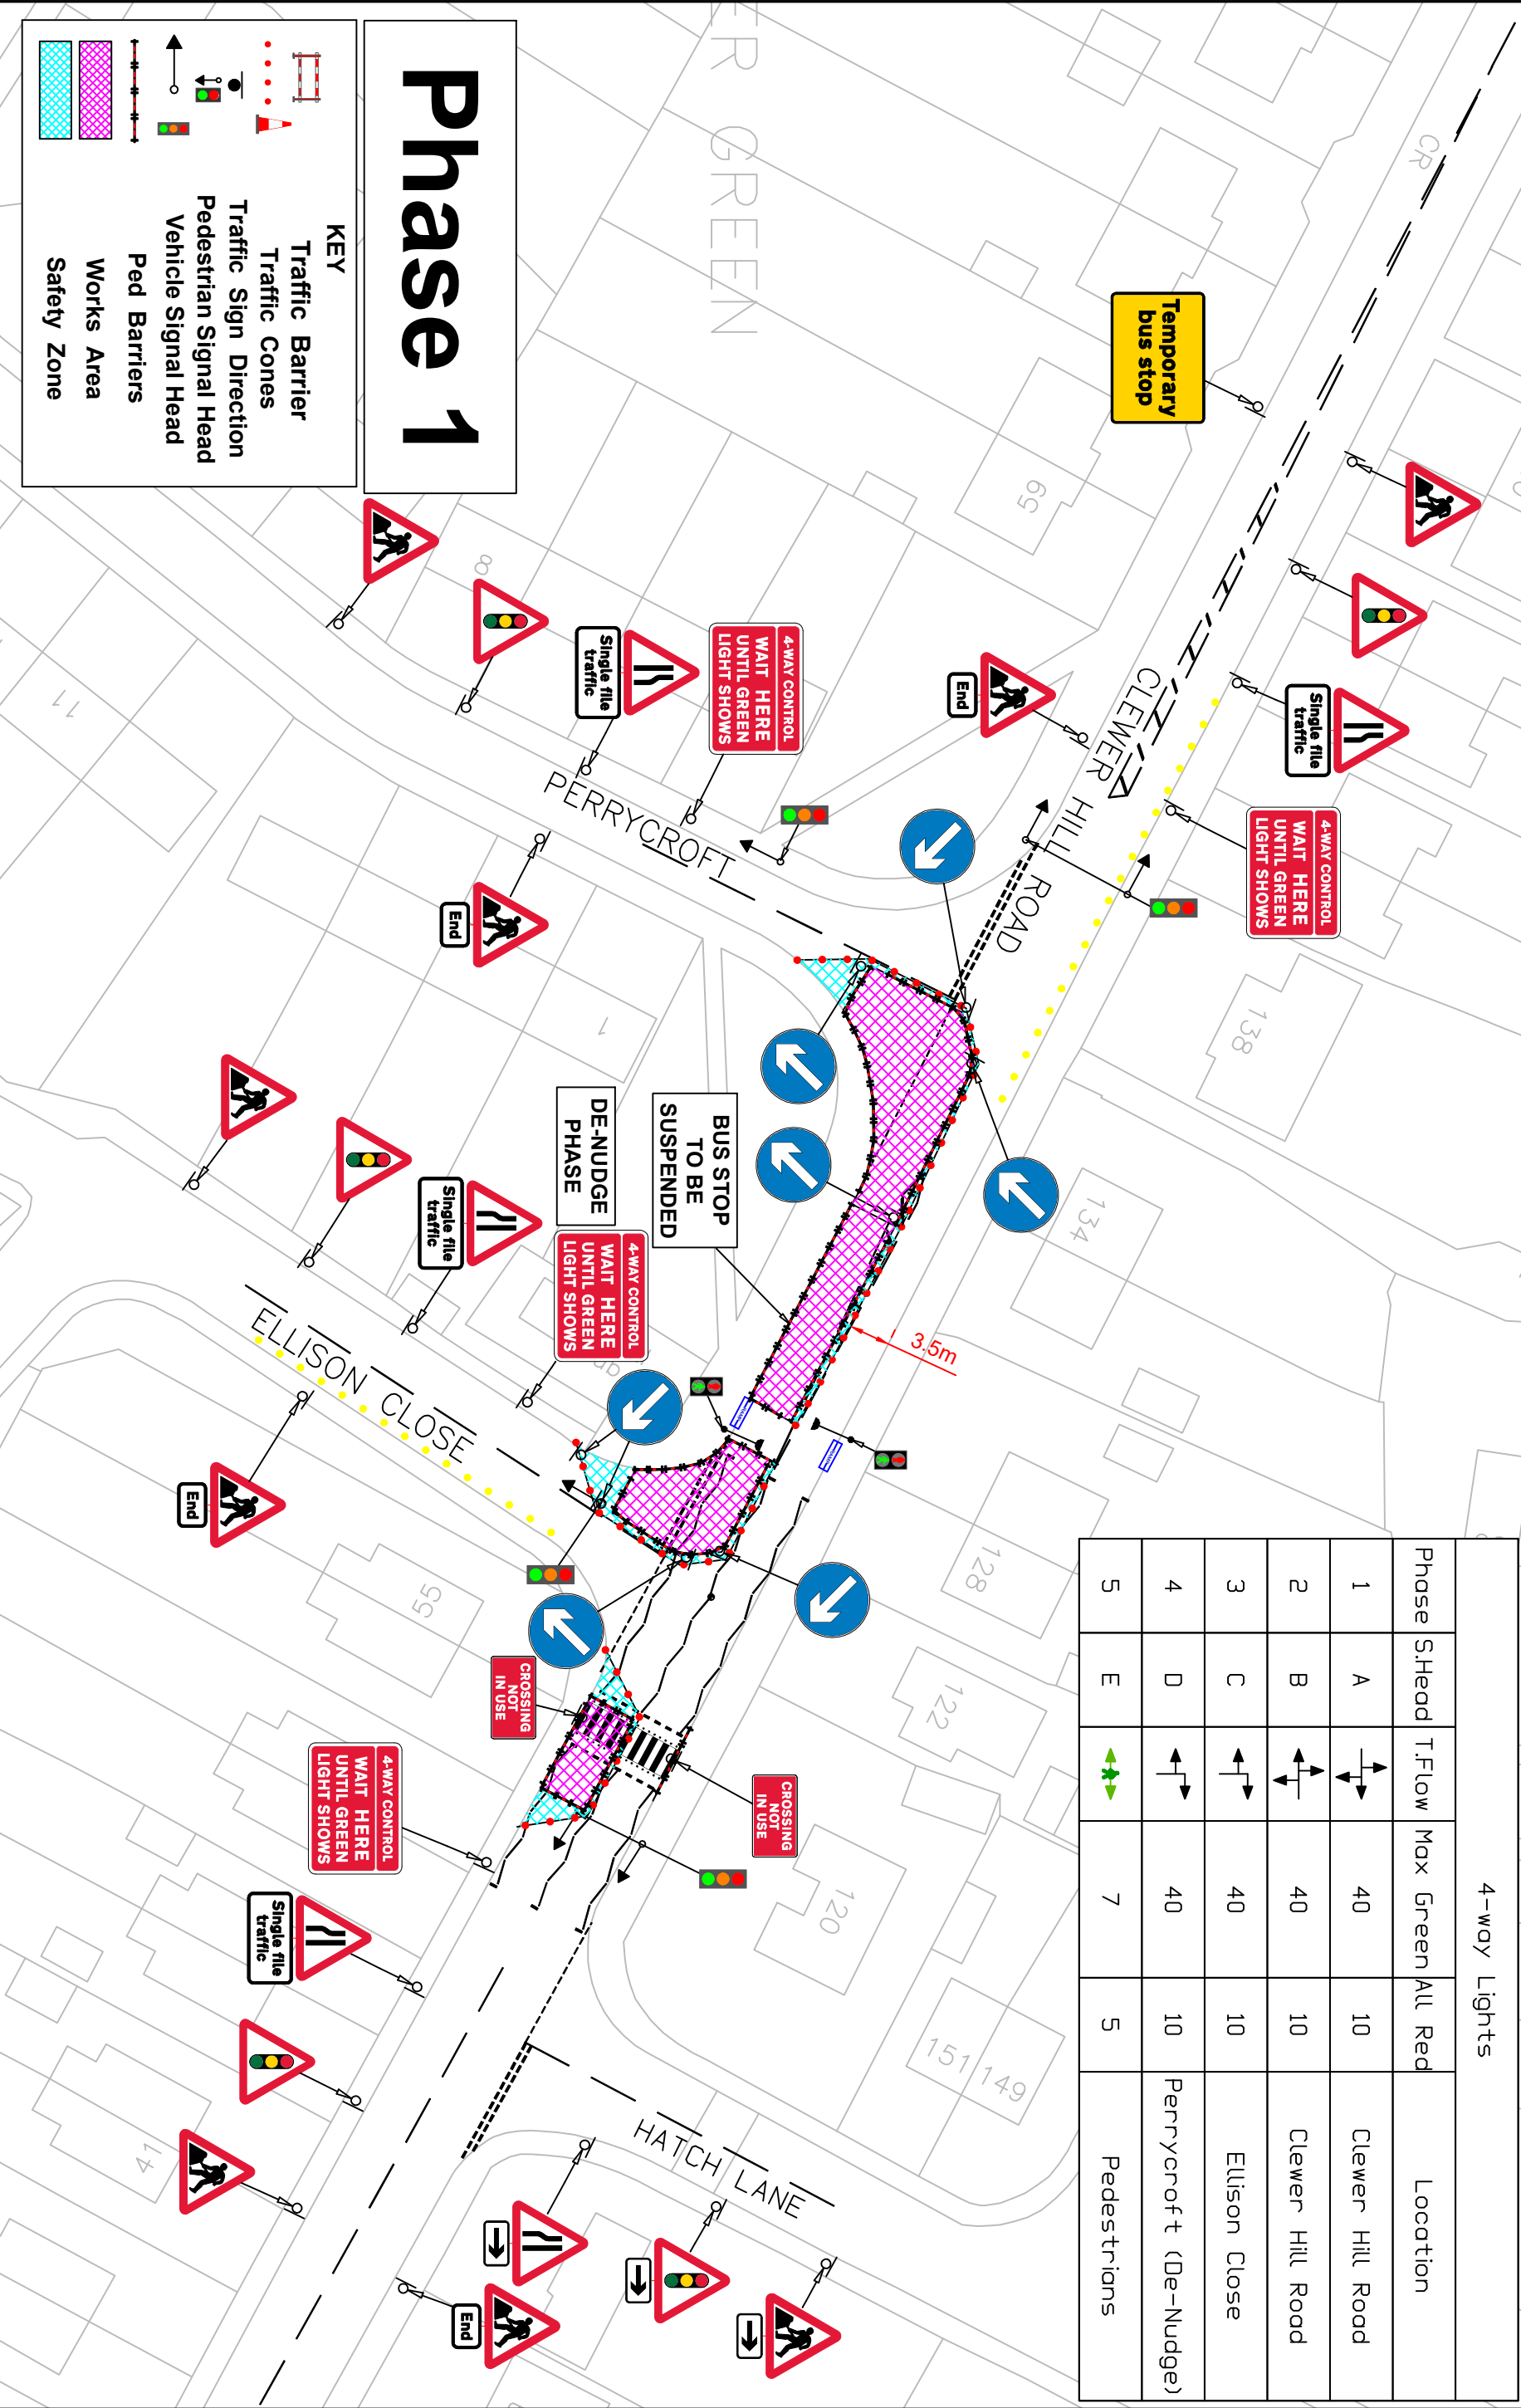
 



4-way Lights					Location
Phase	S.Head	T.Flow	Max Green	All Red	
1	A		40	10	Clewer Hill Road
2	B		40	10	Clewer Hill Road
3	C		40	10	Elison Close
4	D		40	10	Perrycroft (De-Nudge)
5	E		7	5	Pedestrians




KEY



 
Traffic Barrier




Traffic Cones




Traffic Sign Direction




Pedestrian Signal Head




Vehicle Signal Head



Ped Barriers




Works Area





Safety Zone

# Phase 1



 MGROUP  
Water






CLEWER HILL ROAD

WINDSOR

SL4 4BS



Traffic Guarding & Logistics

TGL Group Ltd

Units 3, 4 & 5 River Moles Business Park

Mill Mead Road, Esher,

Surrey KT10 8BJ

Tel: 0800 6444 114

Web: www.tglogroup.co.uk

Email: tmdrawings@tglogroup.co.uk

1) TEMPORARY TRAFFIC MANAGEMENT TO BE SET OUT IN ACCORDANCE WITH CHAPTER 8 AND SAFE WORKING PRACTICES.

2) ALL BUS, PARKING AND LOADING BAYS SHOULD BE SUSPENDED WITH THE RELEVANT AUTHORITY PRIOR TO COMMENCEMENT OF WORK.

3) WORKS VEHICLES TO BE PARKED WITHIN WORKS AREA.

DATE DRAWN19/06/25

DRAWN BYTGL DDC

CHECKED BYTGL CJ

SCALEN.T.S.

Drawing No.

1205.94.6A